




KITCHEN EXHAUST SYSTEM DIAGRAM

NOT TO SCALE E-401

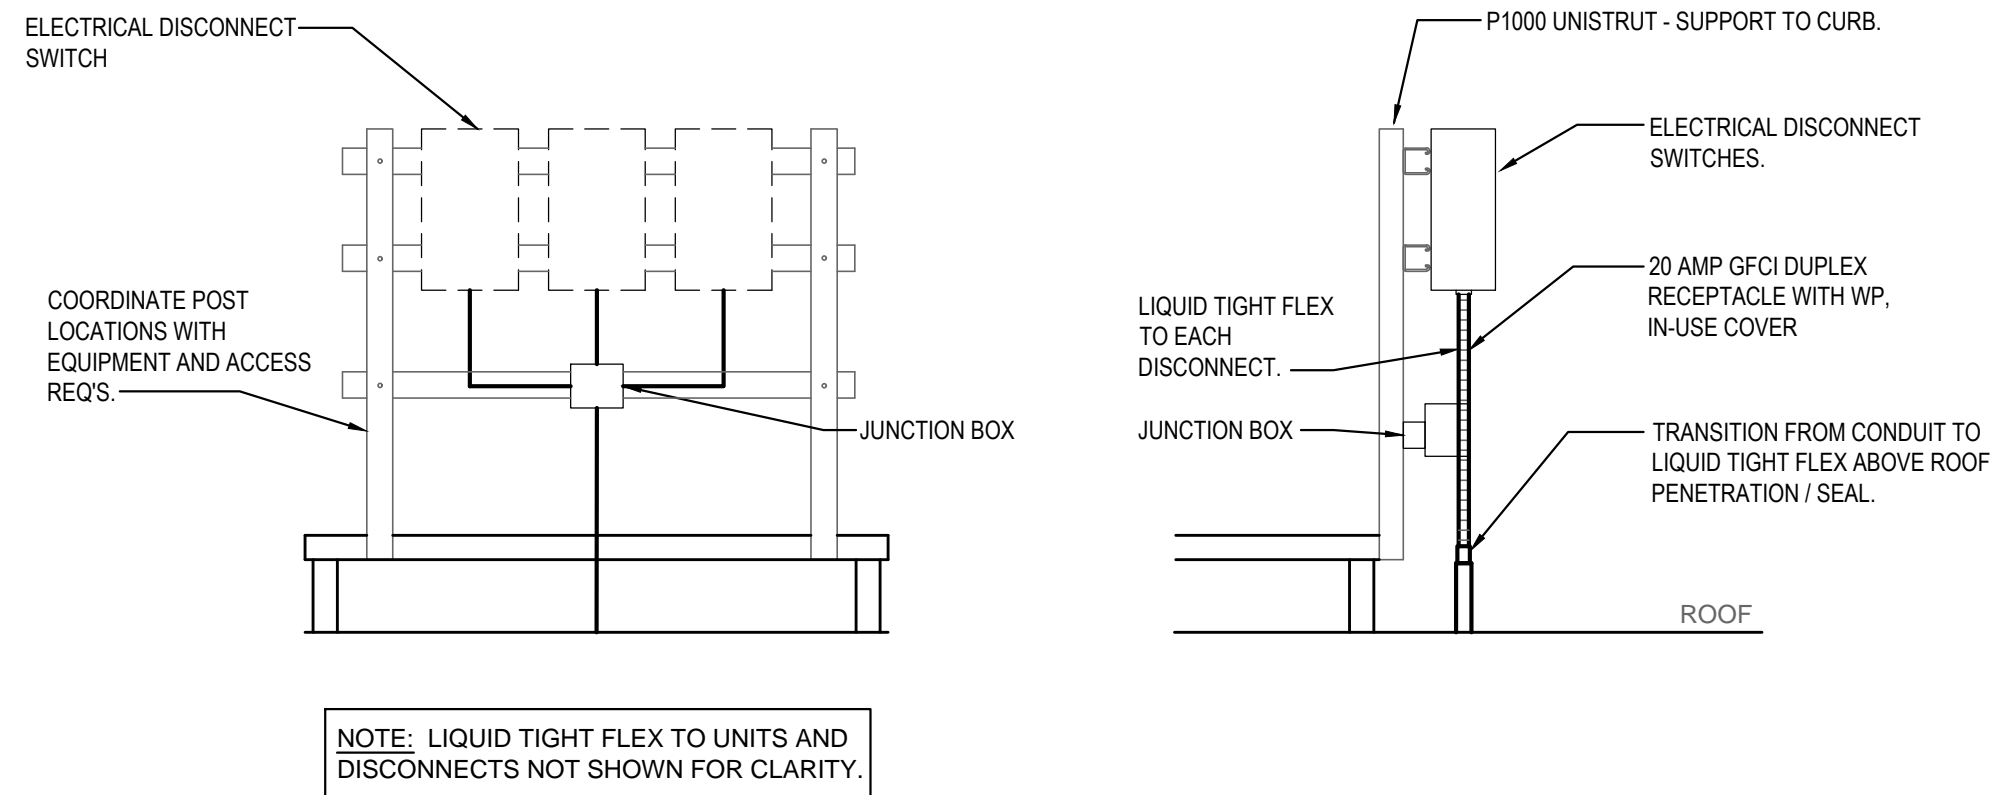

EQUIPMENT DISCONNECT SWITCH SUPPORT

NOT TO SCALE E-401

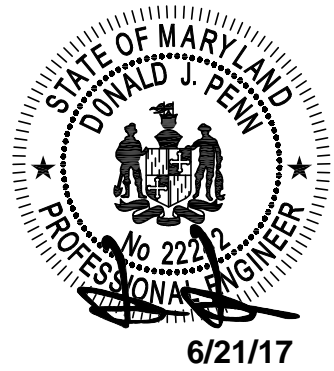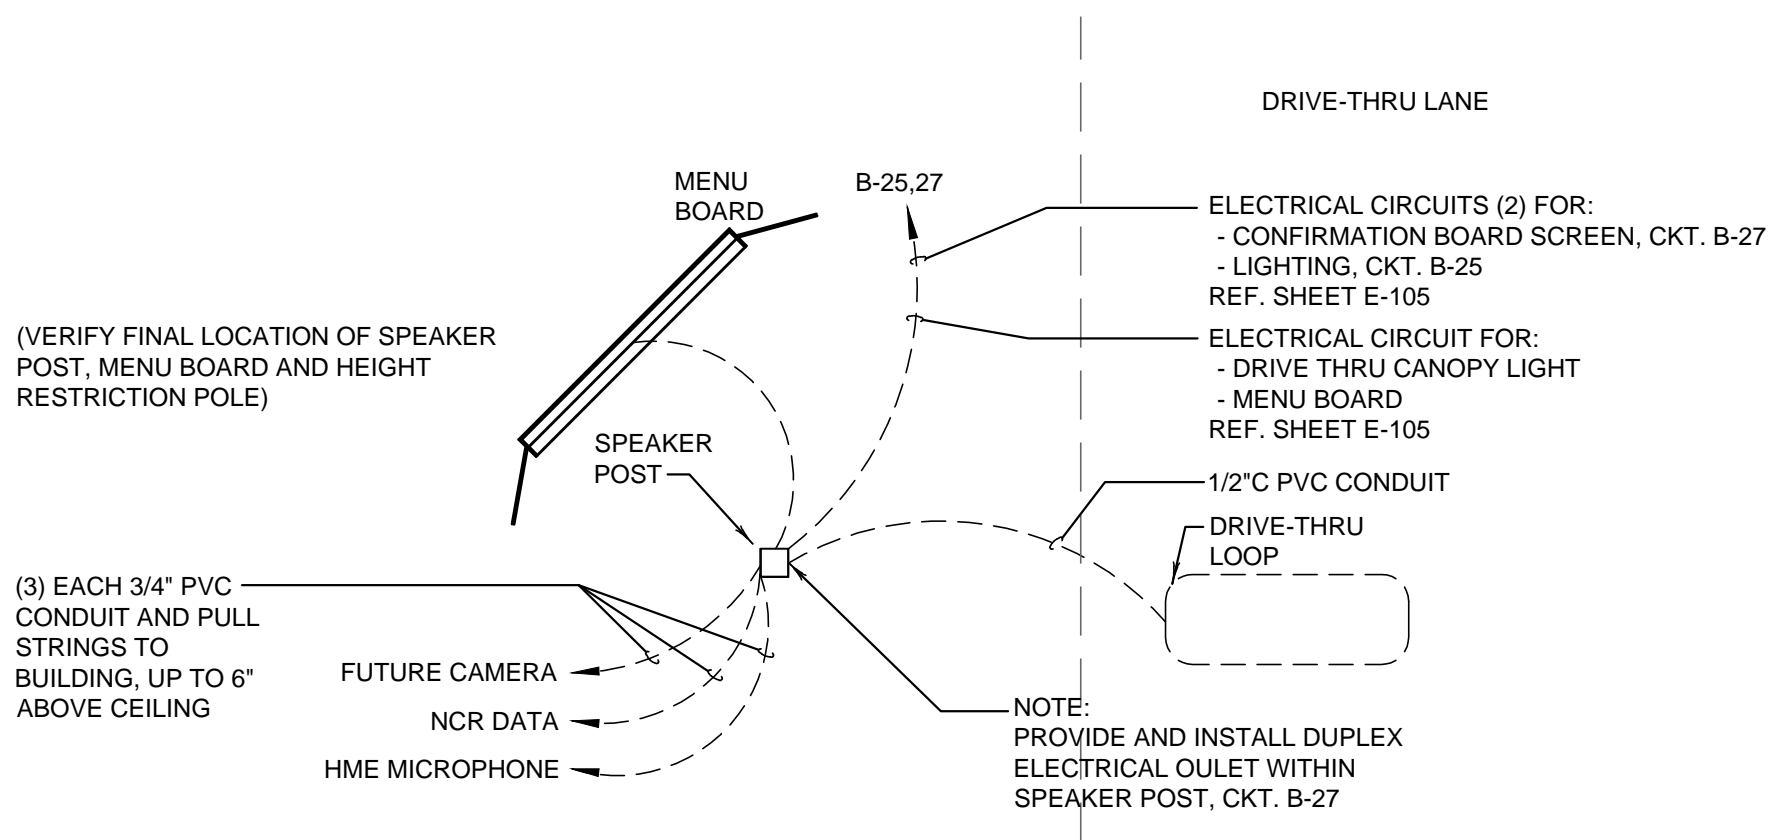

MENU BOARD & SENSOR LOOP

1 E-401



PANDA RESTAURANT GROUP INC.
1683 Walnut Grove Ave.
Rosemead, California
91770
Telephone: 626.799.9898
Facsimile: 626.372.8288

All ideas, designs, arrangement and plans indicated, or represented by this drawing are the property of Panda Express Inc. and were created for use on this specific project. None of these ideas, designs, arrangements or plans may be used by or disclosed to any person, firm, or corporation without the written permission of Panda Express Inc.

REVISIONS:

ISSUE DATE:

1	100% SUBMITTAL

CHECKED BY:

DRAWN BY: STAFF

PANDA PROJECT #: B1-17-D5167

ARCH PROJECT #:

dpce
don penn consulting engineer
1301 SOLANA BLVD., BLDG. 1,
SUITE 1420
WESTLAKE, TEXAS 76262
Phone: 817-410-2858
Fax: 817-251-8411

Professional Certification

I hereby certify that these documents were prepared or approved by me, and that I am a duly licensed professional engineer under the laws of the State of Maryland. License number 22242, Expiration Date: 02/03/19

PANDA EXPRESS

NAS PAX RIVER
PAX RIVER NAVY BASE
PATUXENT RIVER, MD

E-401

ELECTRICAL DETAILS, DIAGRAMS

CONSTRUCTION SET - 2017/07/30