



All ideas, designs, arrangement and plans indicated or represented by this drawing are the property of Panda Express Inc. and were created for use on this specific project. None of these ideas, designs, arrangements or plans may be used by or disclosed to any person, firm, or corporation without the written permission of Panda Express Inc.

REVISIONS:


[illegible]

DRAWN BY: JDV

PANDA PROJECT #: - SX-XX-DXXX
C&P PROJECT #: - 22XXXXX



XX.XX.202

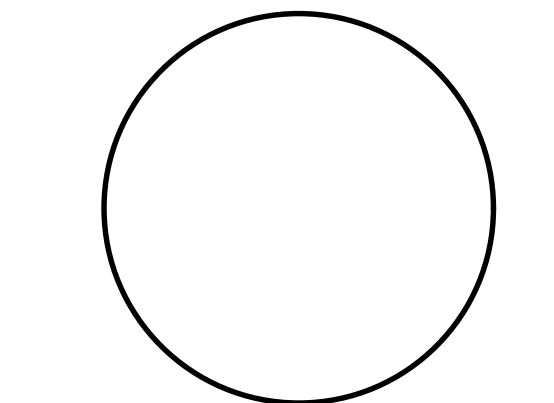

PANDA EXPRESS
TRUE WARM AND WELCOME 2300
STREET ADDRESS
CITY, ST XXXXX

A-500

INTERIOR ELEVATIONS

TRUE WARM & WELCOME 2300 R5

NOTES:

1. ALL EXPOSED WALL, TILE EDGES MUST BE FINISHED TO MATCH TILE SURFACE. EASE TILE EDGE AS ALLOWABLE.
2. BLINDS SHALL BE PROVIDED BY OWNER AND INSTALLED BY VENDOR. COORDINATE WITH PANDA PROJECT MANAGER PRIOR TO INSTALLATION
3. PROVIDE 1/2" CLEAR PLASTIC CORNER GUARD FOR ALL INTERIOR PAINTED SURFACE W/ CLEAR GLUE.
4. ALL TILES INSTALLED NOT TO BE CUT LESS THAN 1/2 THE TILE WIDTH.
5. REFERENCE SHEET A-103 FOR WALL PANEL SCHEDULE
6. REFERENCE SHEET A-103 FOR SPECIAL SURFACE SCHEDULE
7. REFERENCE SHEET A-103 FOR INTERIOR PAINT SCHEDULE
8. REFERENCE SHEET A-104 FOR TILE SCHEDULE
9. REFERENCE SHEET A-104 FOR EXTENT OF COVE TRIM AT BASE

GENERAL DECOR NOTE:
ALL WALL DECORATIONS, PRINT LOCATIONS,
ETC... TO BE VERIFIED WITH PANDA EXPRESS
BY G.C.


G.C. SHALL PROVIDE/INSTALL ANY
CONCEALED BACKING, MISC. HARDWARE NOT
PROVIDED BY OWNER, ETC... AS REQUIRED.

COORDINATE LOCATION OF ALARM DEVICES
WITH ARTWORK (IF REQUIRED).

G.C. SHALL PROVIDE/INSTALL ANY CONCEALED BACKING, MISC. HARDWARE NOT PROVIDED BY OWNER, ETC... AS REQUIRED.


COORDINATE LOCATION OF ALARM DEVICES WITH ARTWORK (IF REQUIRED).

COORDINATE LOCATION OF ALARM DEVICES
WITH ARTWORK (IF REQUIRED).

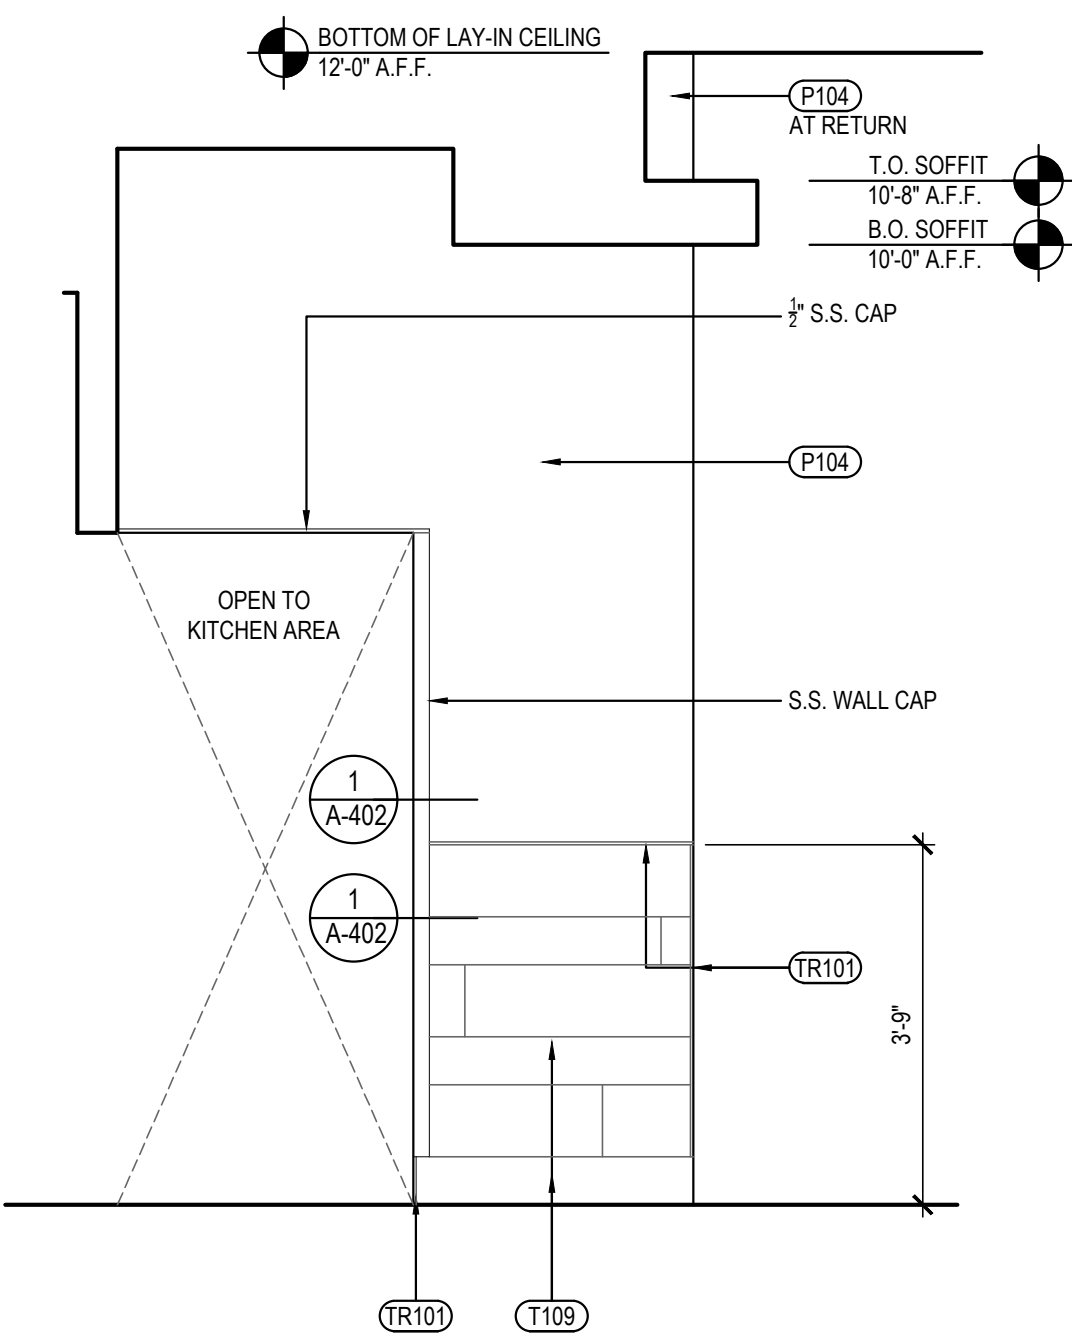


DINING ROOM ELEVATION	4
-----------------------	---

Scale= 1/2" = 1'-0" | A-51

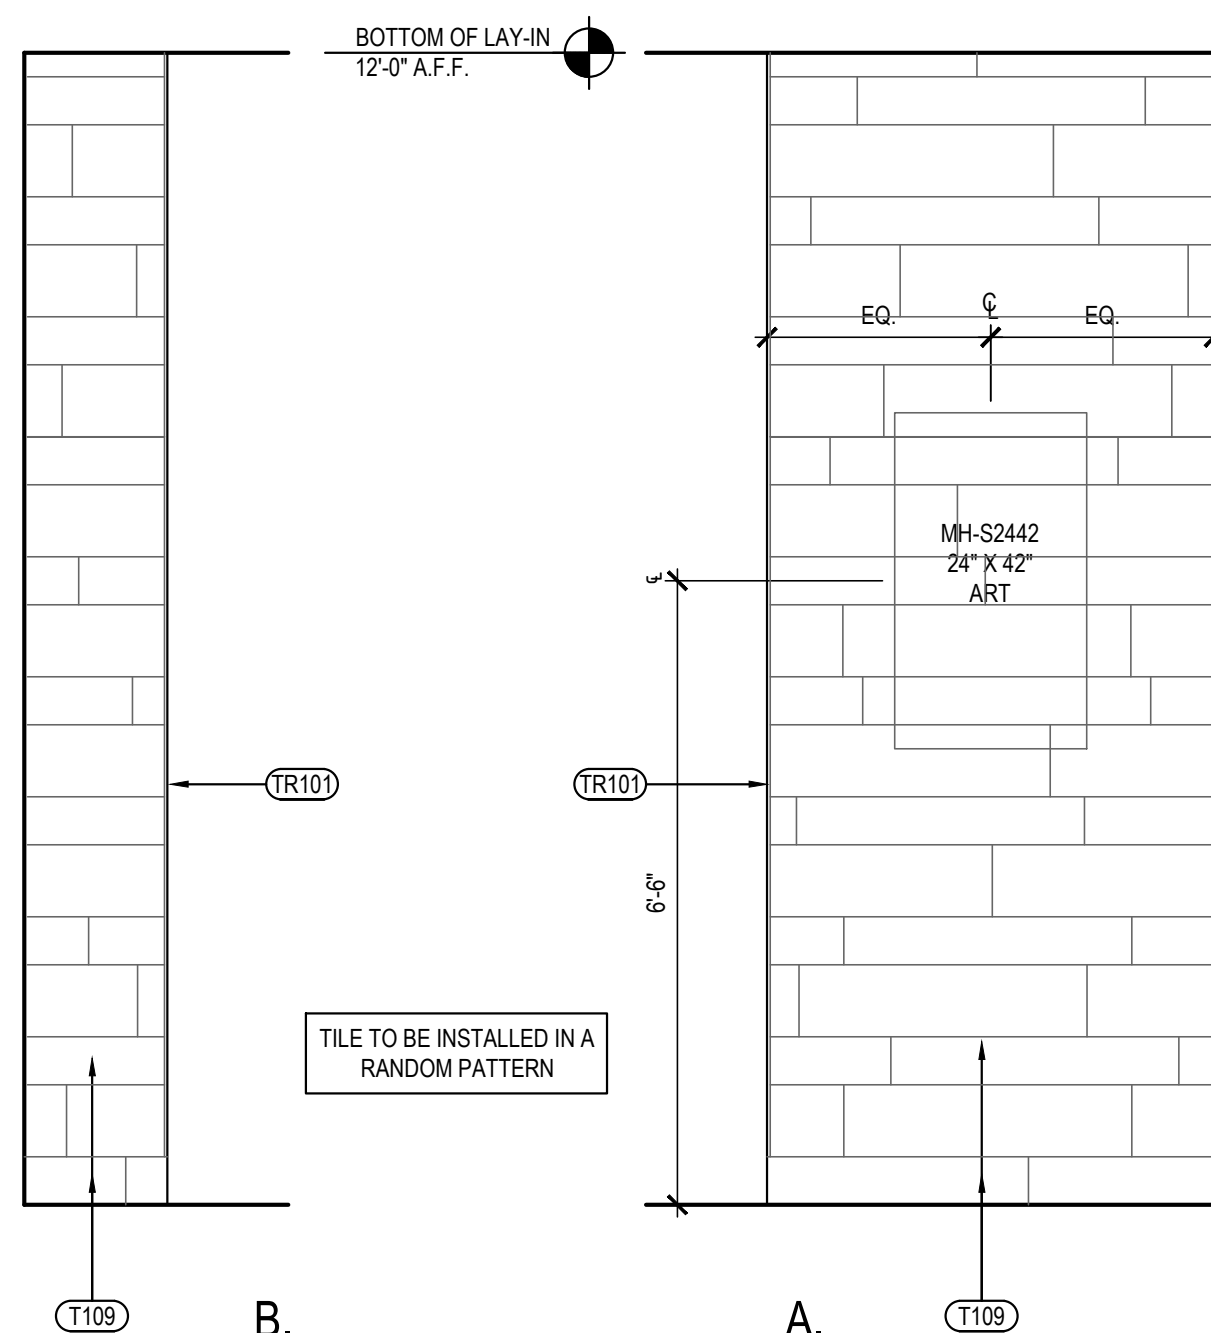


DINING ROOM ELEVATION	3
-----------------------	---

Scale= 1/2" = 1'-0" | A-50

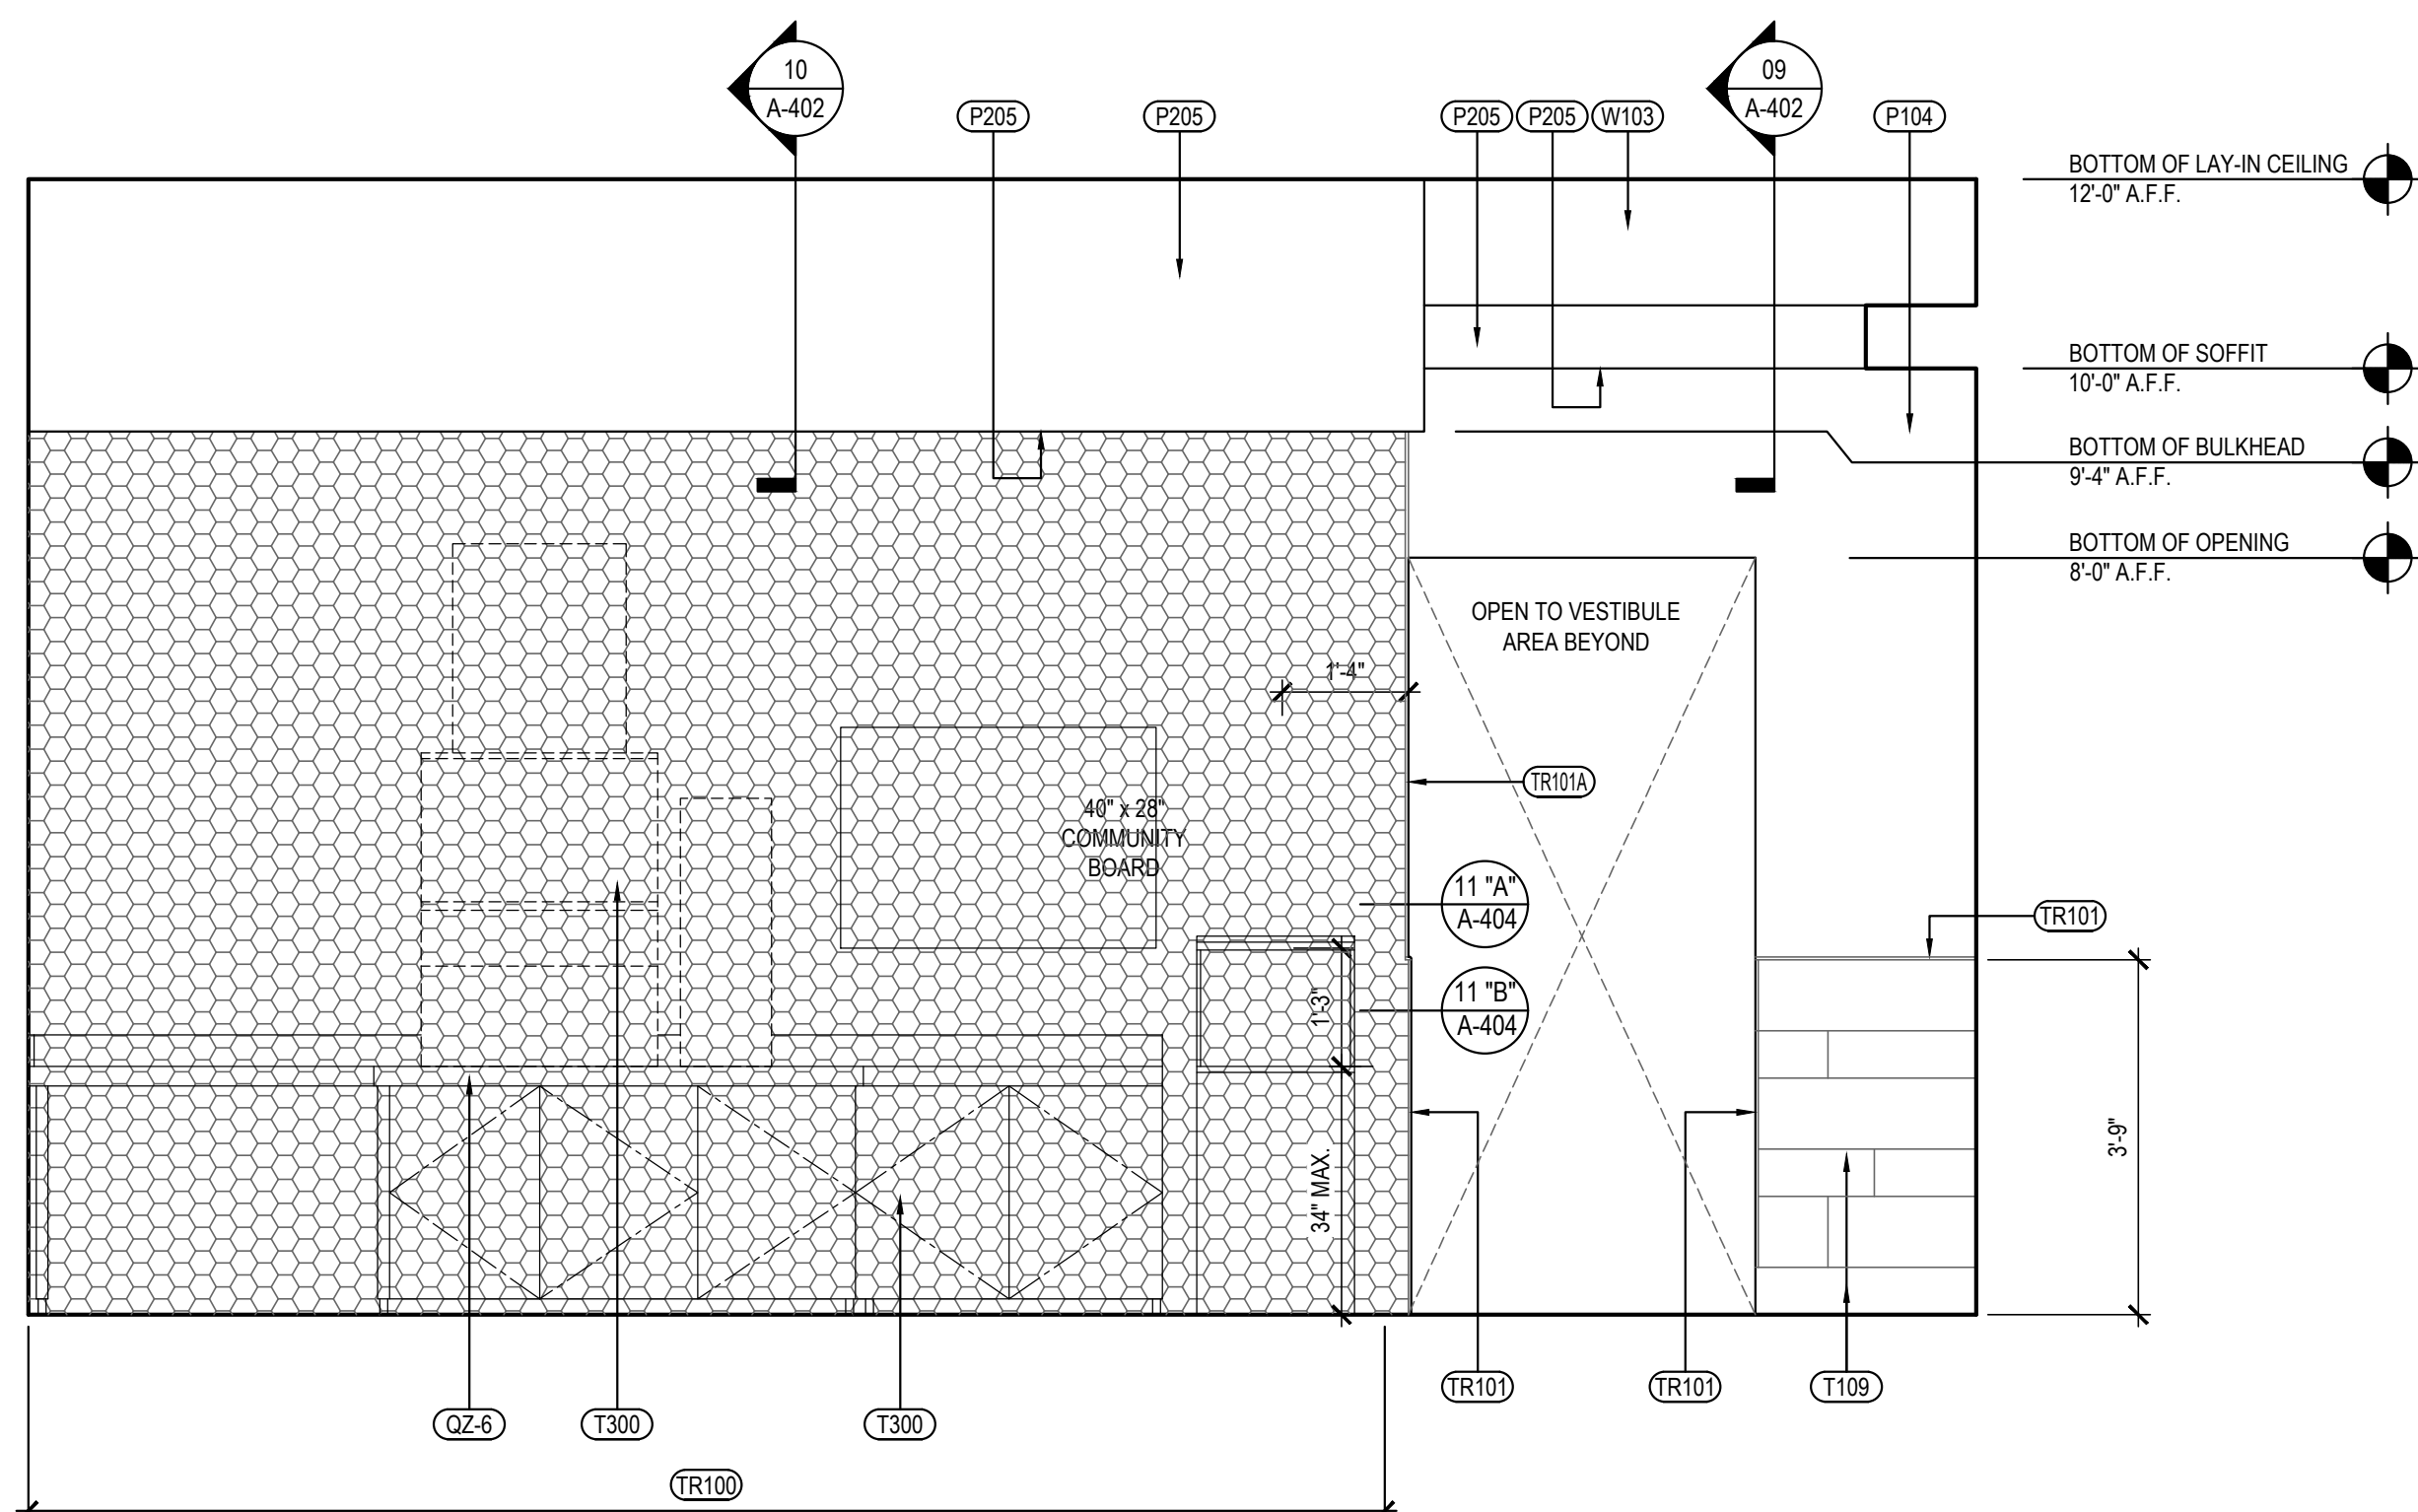

DINING ROOM ELEVATION | 2

Scale= 1/2" = 1'-0" | A-5

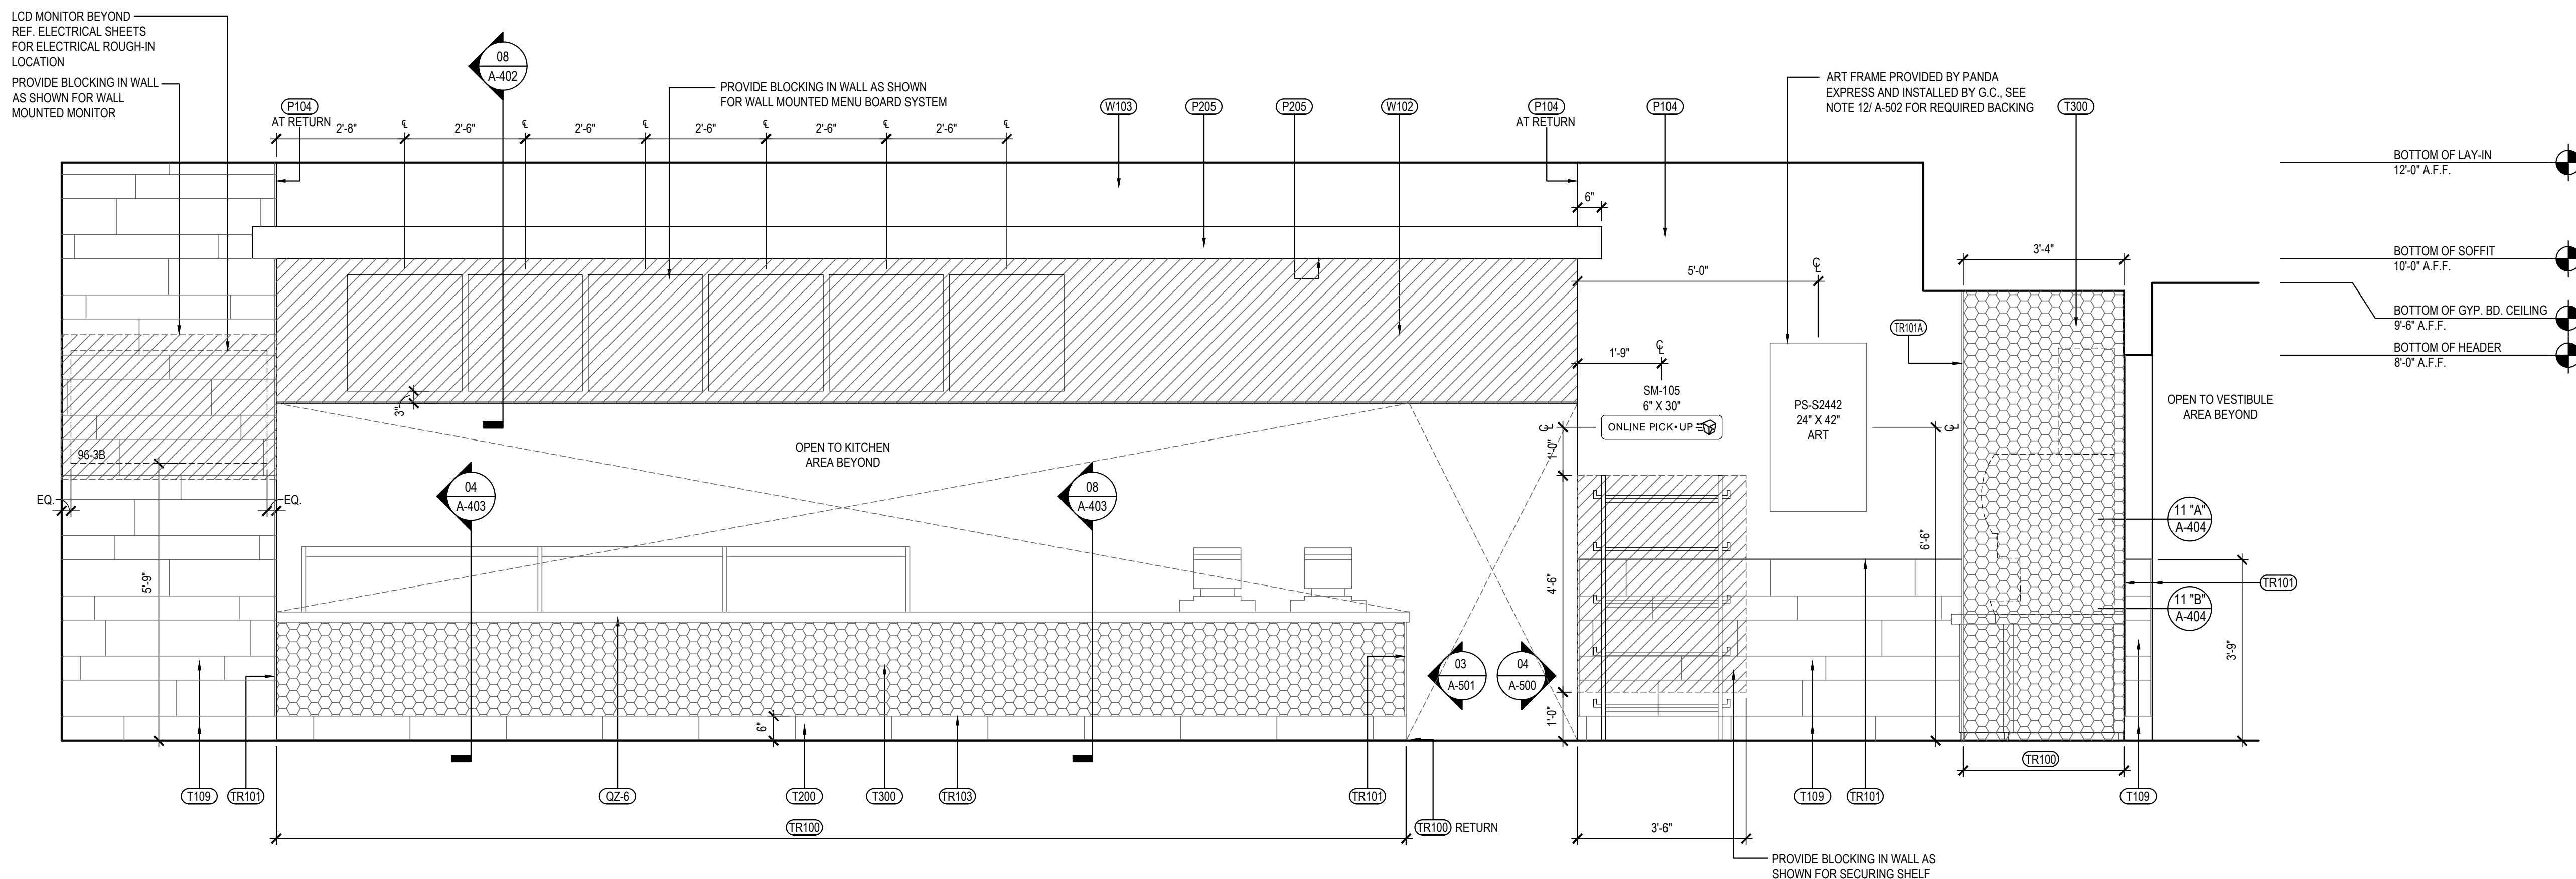

DINING ROOM ELEVATION

Scale= 1/2" = 1'-0"

-0"	A-500
-----	-------