




REFER TO
SHEET E-003
FOR KEYNOTES

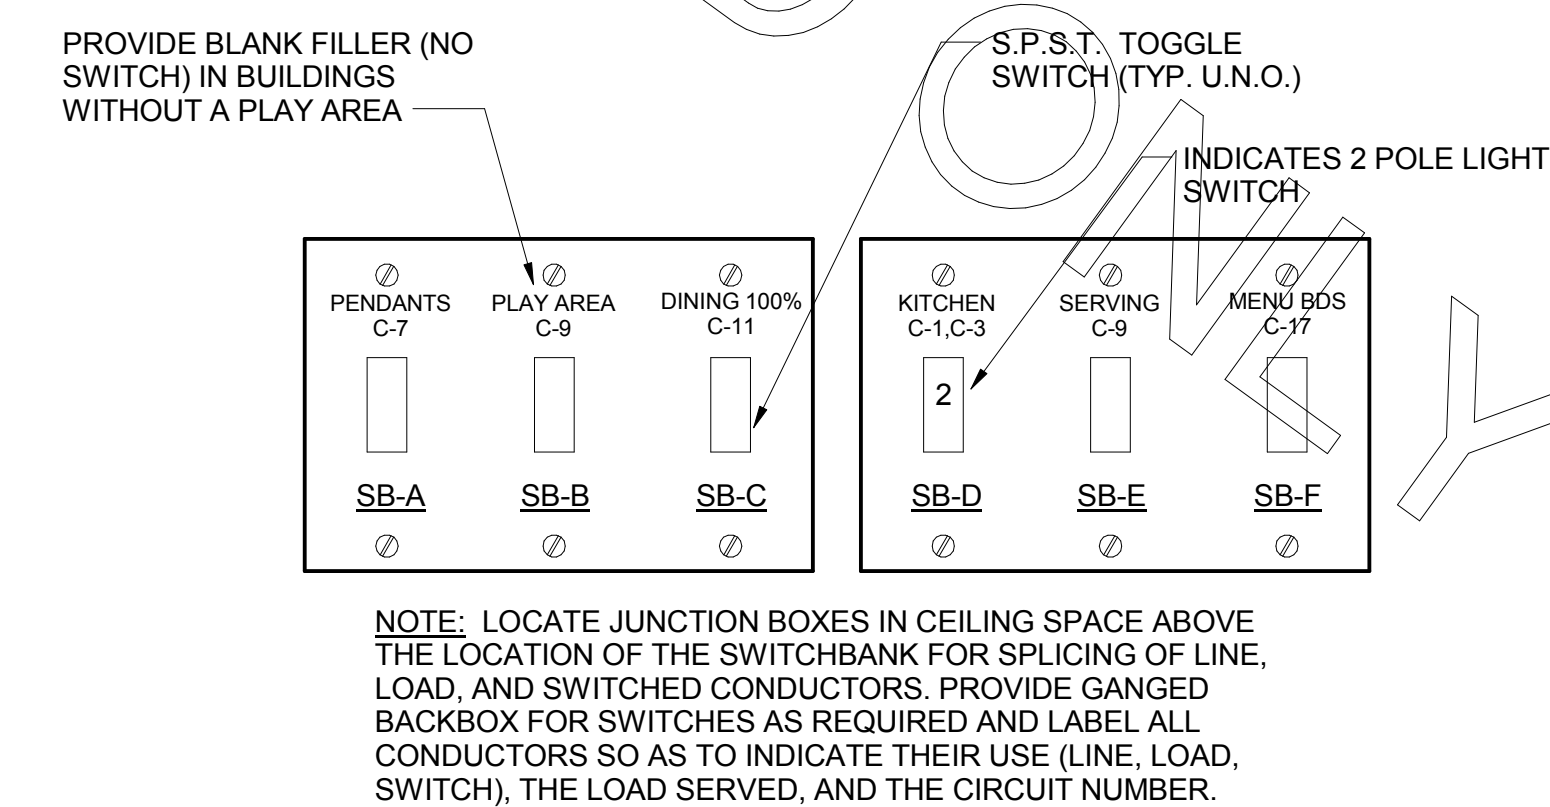

A1 SWITCH BANK "SB" DETAIL
NO SCALE



CHICK-FIL-A
Cherokee Place, FSR
115 Cherokee Place, Cartersville, GA
30121

REVISION SCHEDULE		
NO.	DATE	DESCRIPTION
3	01.12.18	CITY COMMENTS
5	03/12/18	COORDINATION REVISIONS

CONSULTANT PROJECT #	2017.0149
PRINTED FOR	Bld
DATE	11.20.17
DRAWN BY	Designer

SHEET
LIGHTING PLAN -LRG

SHEET NUMBER

E-211L

Bid

E-211L

3/12/2018 4:35:28 PM